
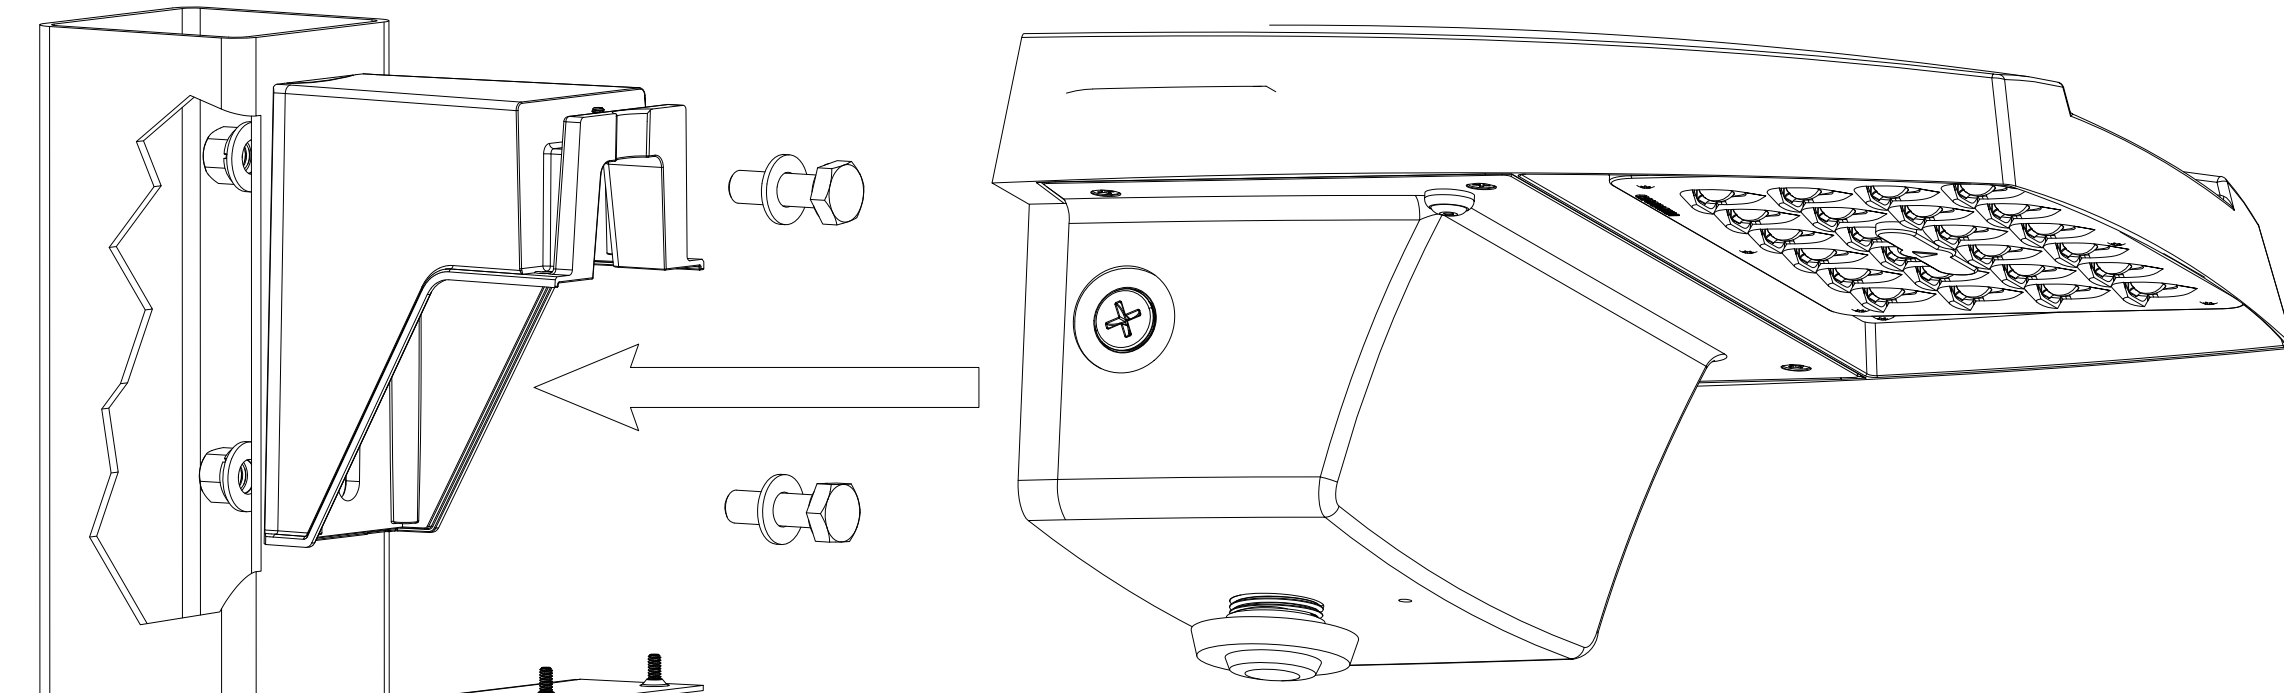


**LIGHTING PLAN**  
SCALE: 1"=60'

**LEGEND / ABBREVIATIONS**

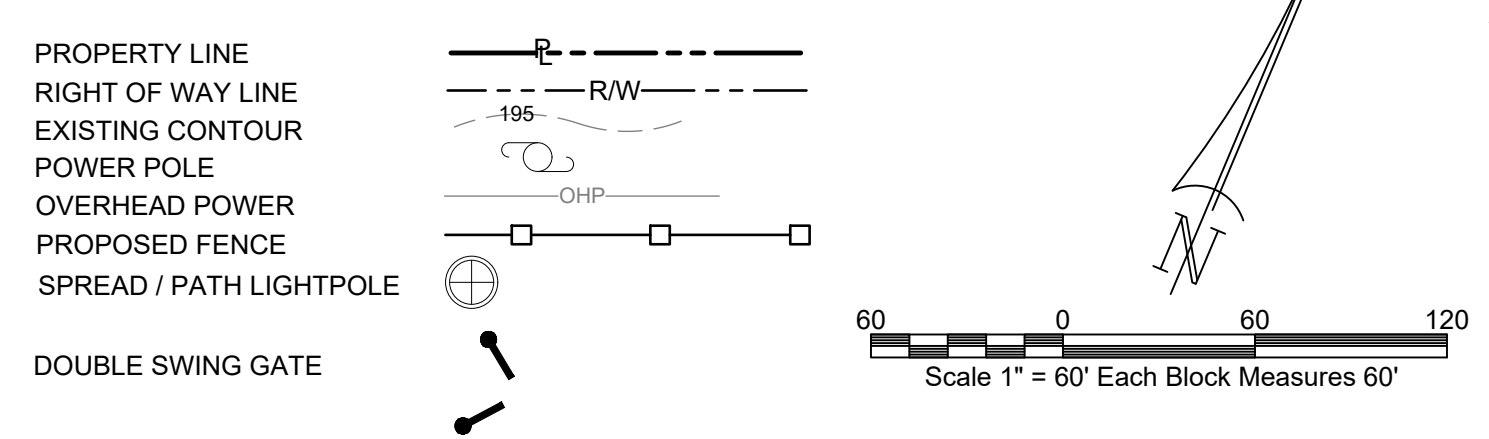

**DETAIL, COMMERCIAL LUMINAIRE FIXTURE - SPREAD PATH TYPE**  
**MANUFACTURER & MODEL, LUMARK PRV-P**  
SCALE: NONE

**LUMINAIRE INFORMATION:**


Manufacturer: Lumark  
Model: Prevail P (PRV-P)  
Lamp: LED  
Class: Commercial  
Pattern: Area  
Distribution: Type II  
Shielded: Yes

**SPECIFICATIONS:**


Panel Geometry: Rectangle  
Panel Count: 1  
Driver: Dimming, 0-10V  
Voltage: 120-277V  
Color Temp: 70CRI, 4000K  
Output: 4,900 Nominal Lumens  
Mount: Standard Arm  
Support: Pole

**CERTIFICATIONS:**


Approved by:  
DarkSky International

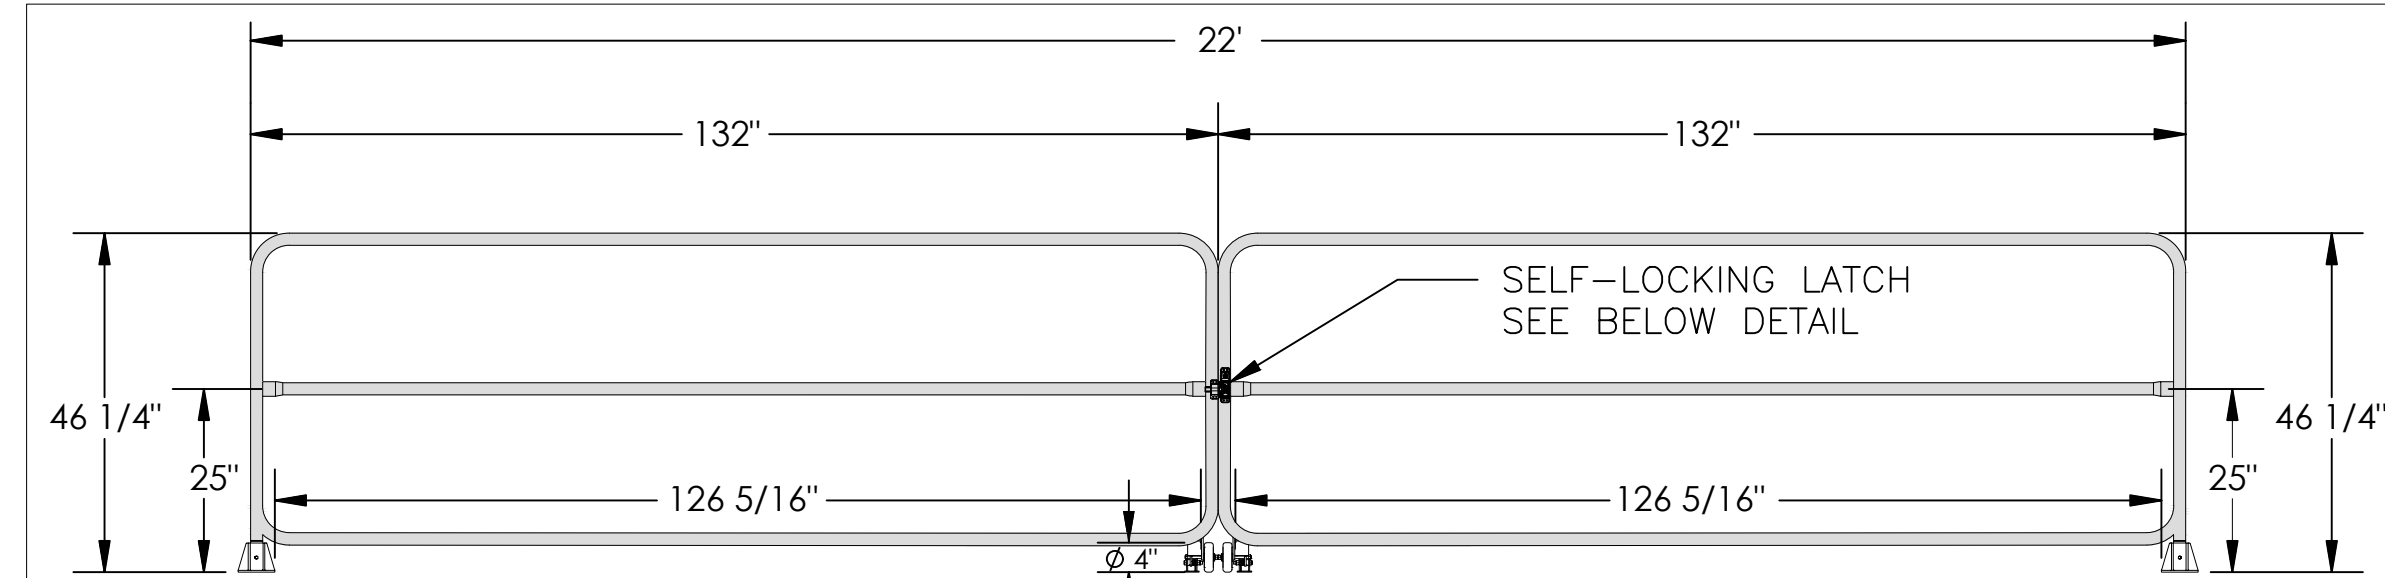

**DETAIL, SECURITY GATE PROFILE, TYP. - DOUBLE-SWING TYPE**  
SCALE: NONE

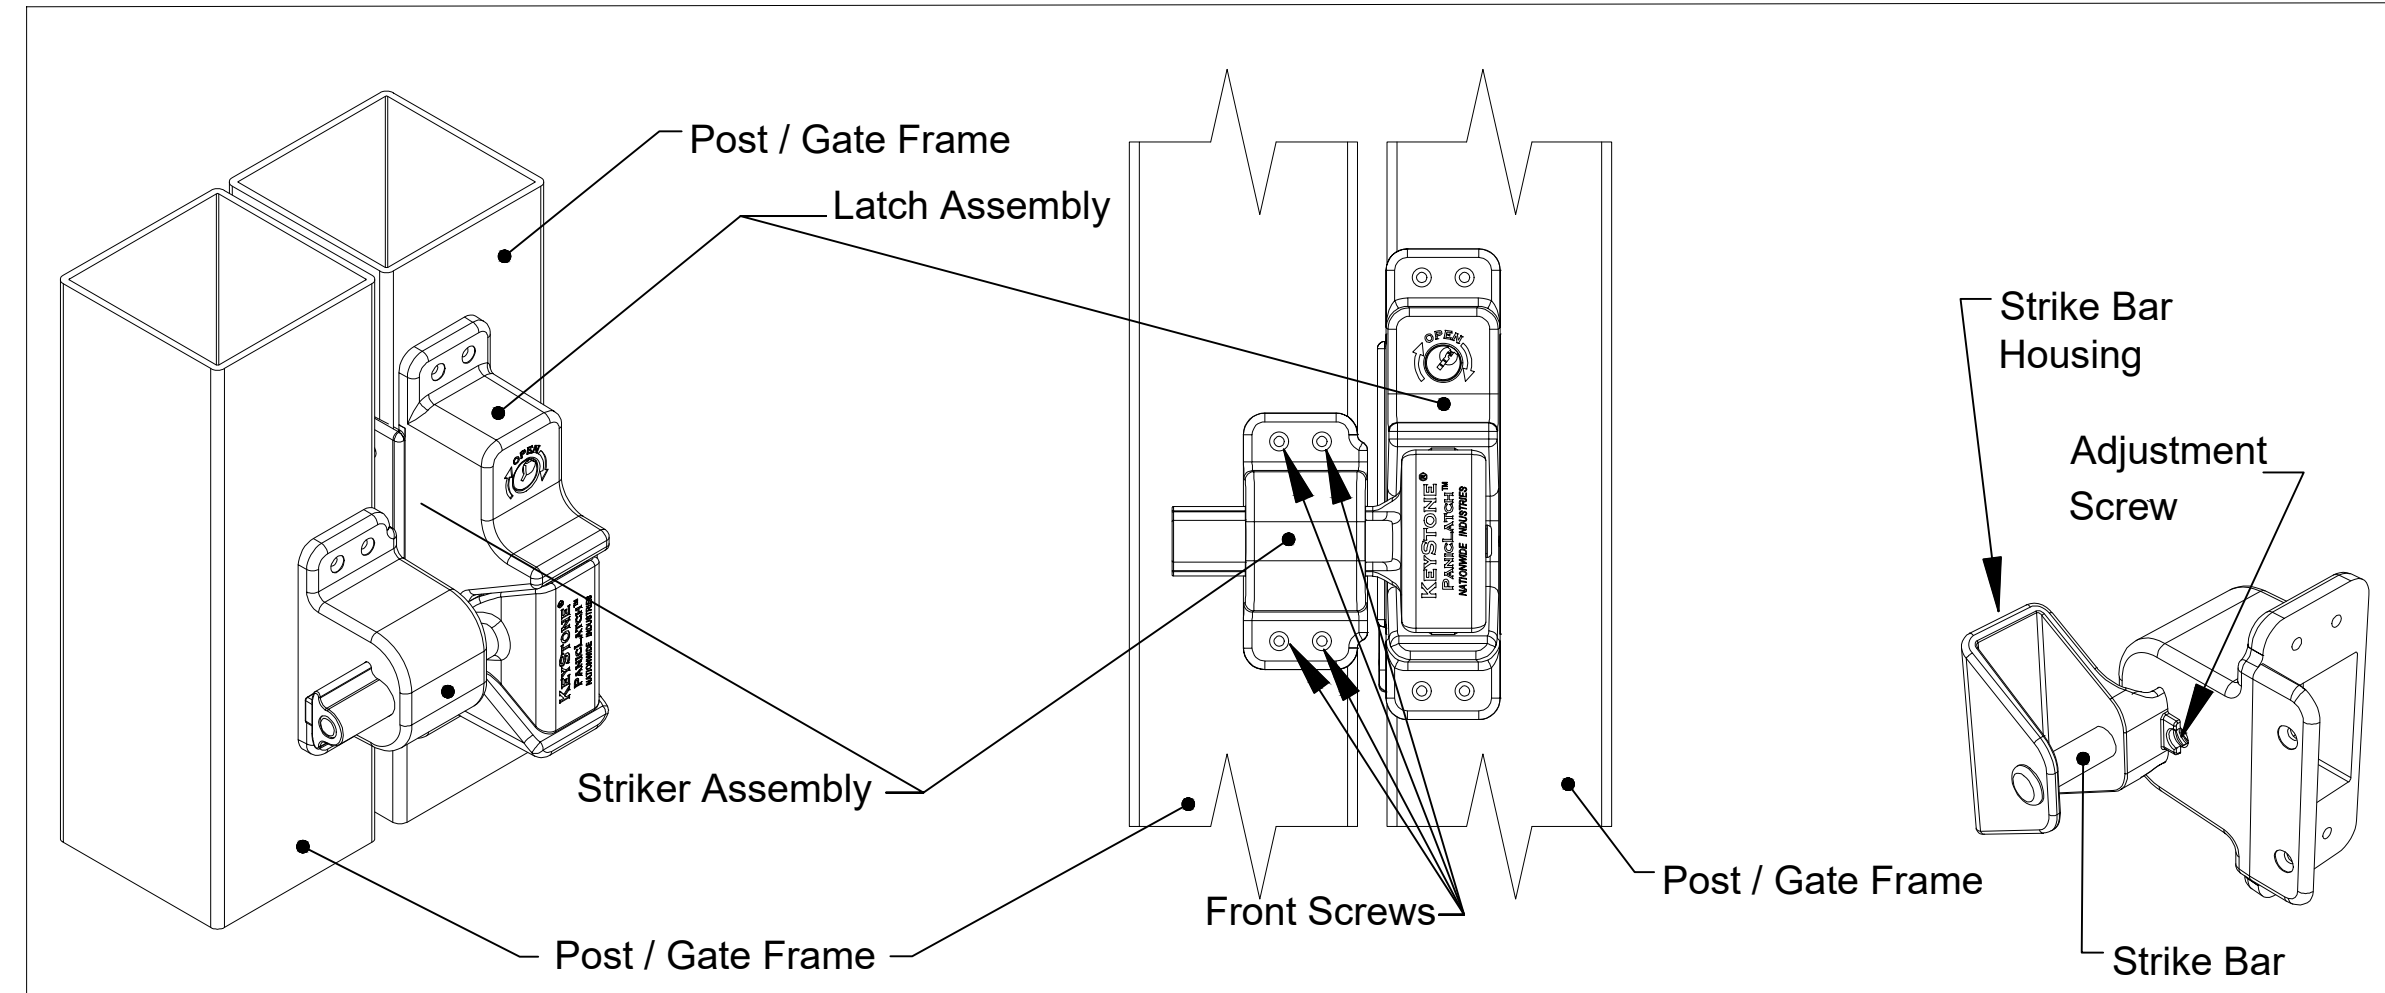

**DETAIL, COMMERCIAL GATE LATCH - SELF-LOCKING TYPE**  
**MANUFACTURER, NATIONWIDE INDUSTRIES**  
**MODEL, KEYSTONE PANICLATCH (KPL), MPN, KPL-P2-BK**  
SCALE: NONE

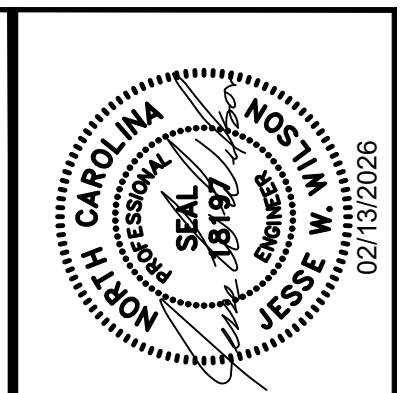

1001 CHESTNUT DRIVE  
SMITHFIELD, NC 27577  
(336) 736-9267



REV. NO.	DESCRIPTION	DATE	BY
1	ADDED GATE & LATCH DETAIL	02/13/20	JWW

**PHILLIPPE BORROW PIT & LCD LANDFILL**  
**LIGHTING PLAN & GATING DETAILS**  
**KENNETH PHILLIPPE**  
**4115 CLAPP MILL ROAD**  
**BURLINGTON, NC 27215**

PROJECT NUMBER	24-PHILLIPPE-01
DESIGNED BY	JWW
DRAWN BY	CSH
CHECKED BY	JWW
SCALE	AS NOTED
DATE	02/05/2020